
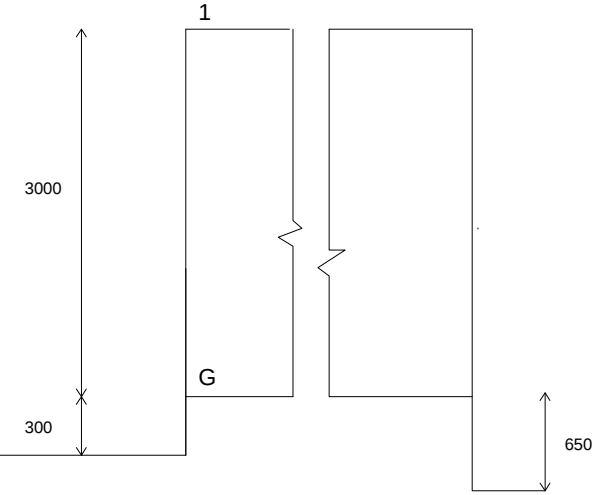


Flat 1/2 14 Havelock Street, Glasgow

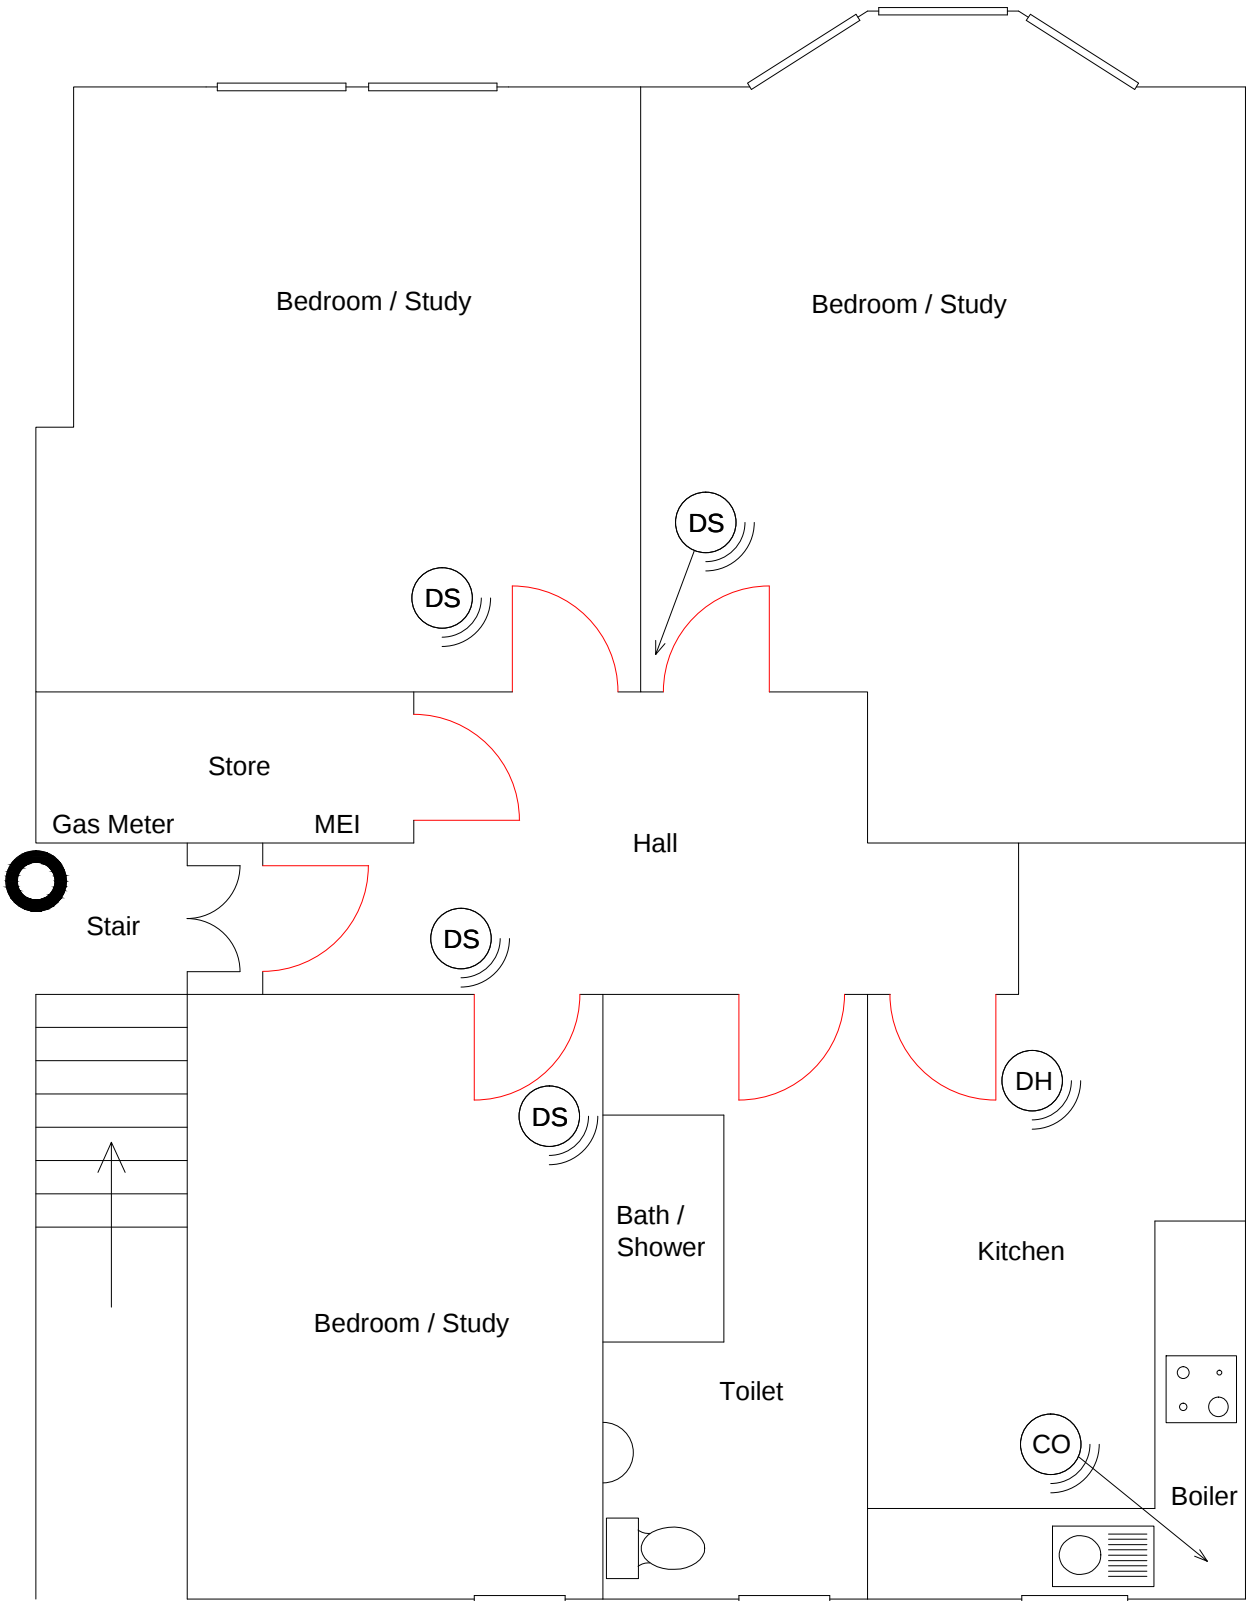


Flat 1/2
14 Havelock Street
Glasgow
G3 7DW

Drawing	Floor Plan/Section
Drawing Number	14/1/2/01
Scale	1/50
Date	July, 2015


Group 3 Energy
28 Nelson Street
Kilmarnock
KA1 1BA
01563 529537

Key to fire Strategy Drawing

Fire Door, 30 min, S/C

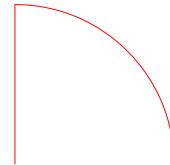

Smoke detector with sounder

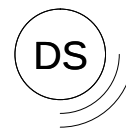

Heat detector with sounder




Escape Lighting




Exit Sign



Carbon Dioxide Extinguisher

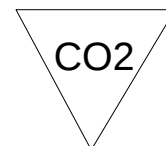

Foam Extinguisher

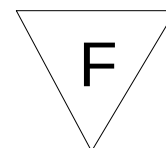

Water Extinguisher

